




"Golden grain" coffee shop interior design, for unit Kingsway, BR49 JF

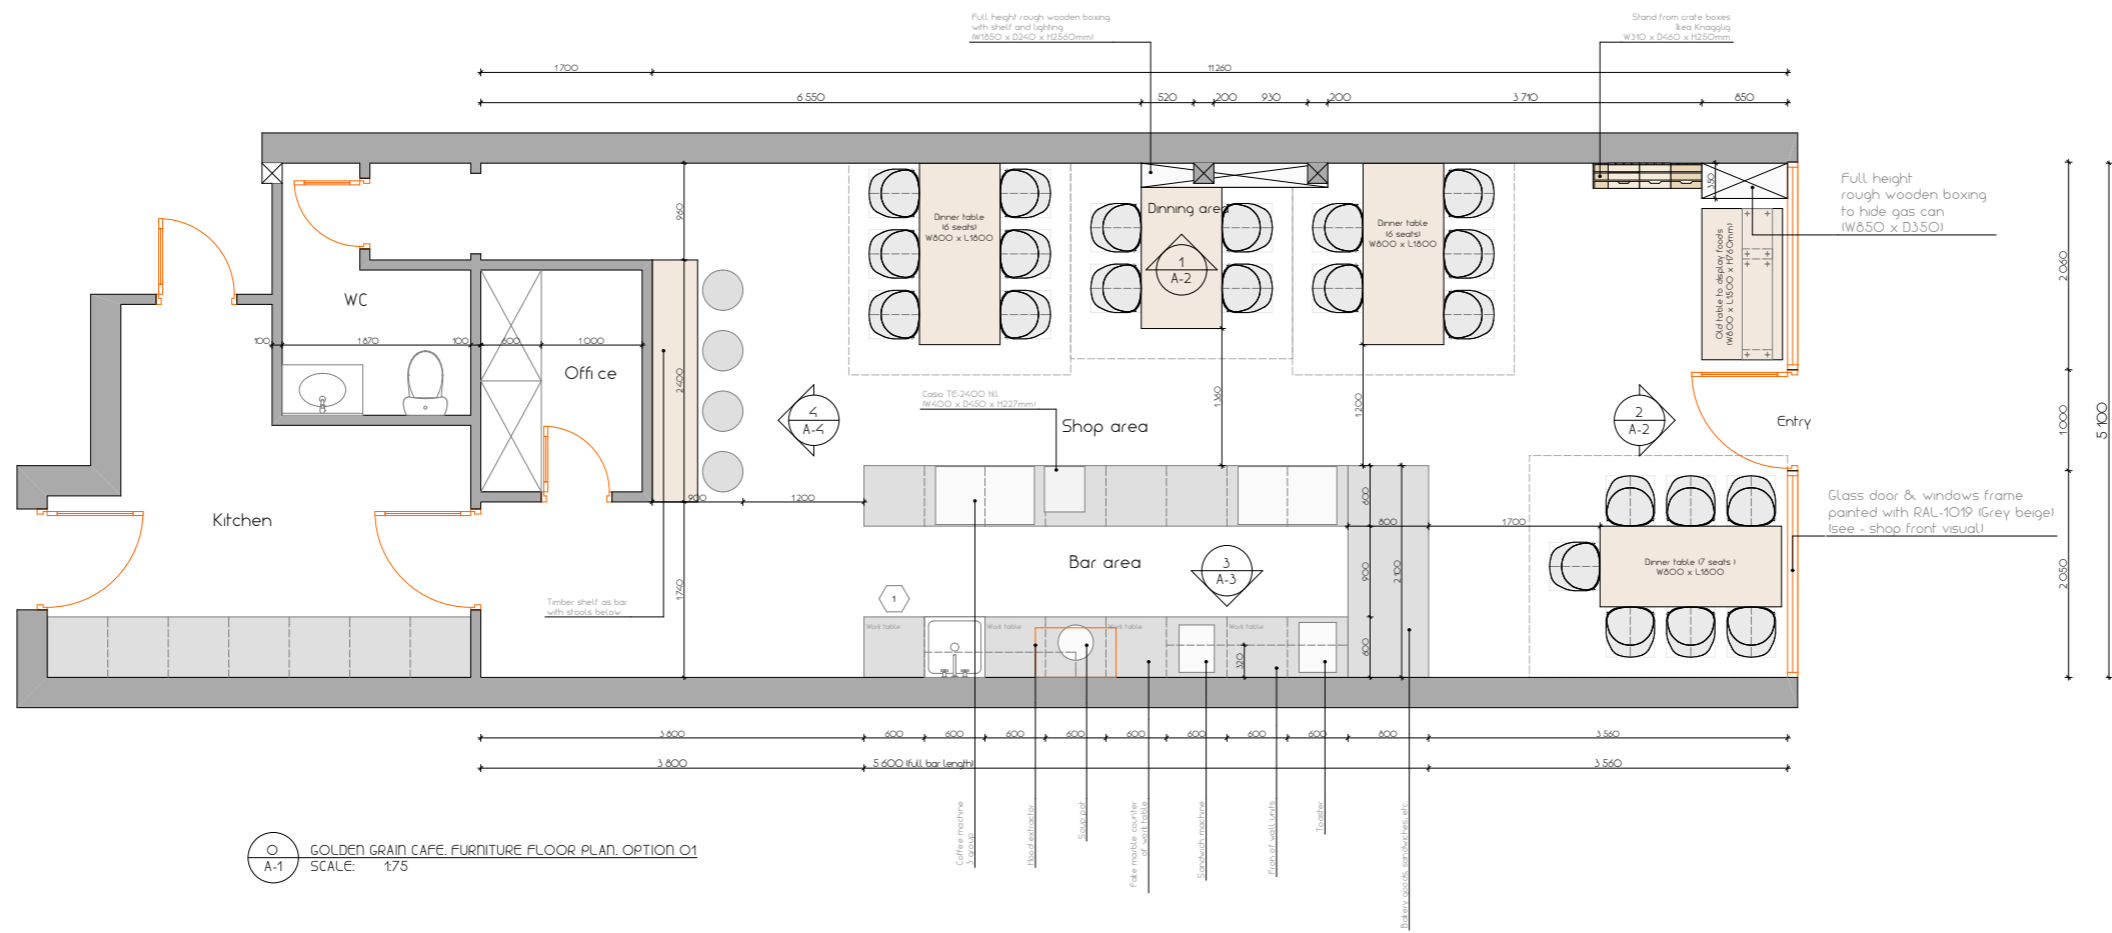


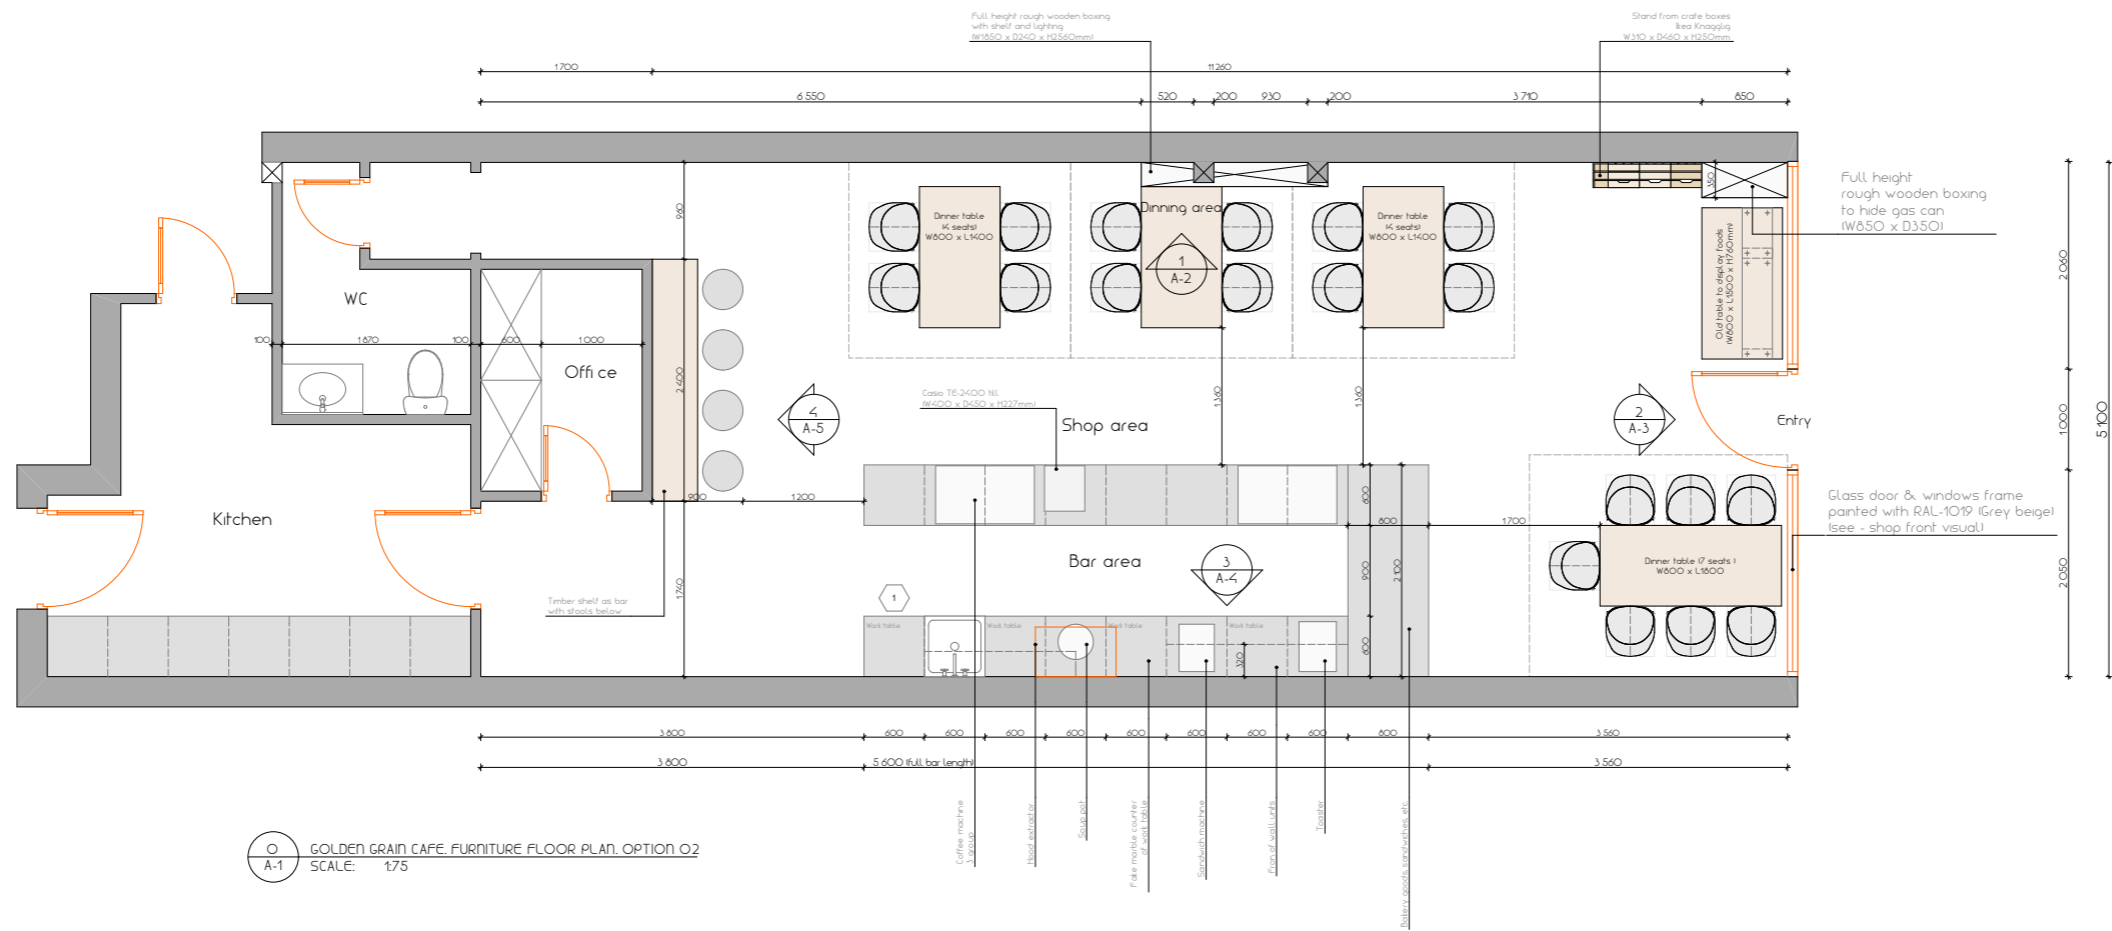


"Golden grain" coffee shop interior design, for unit Kingsway, BR49JF

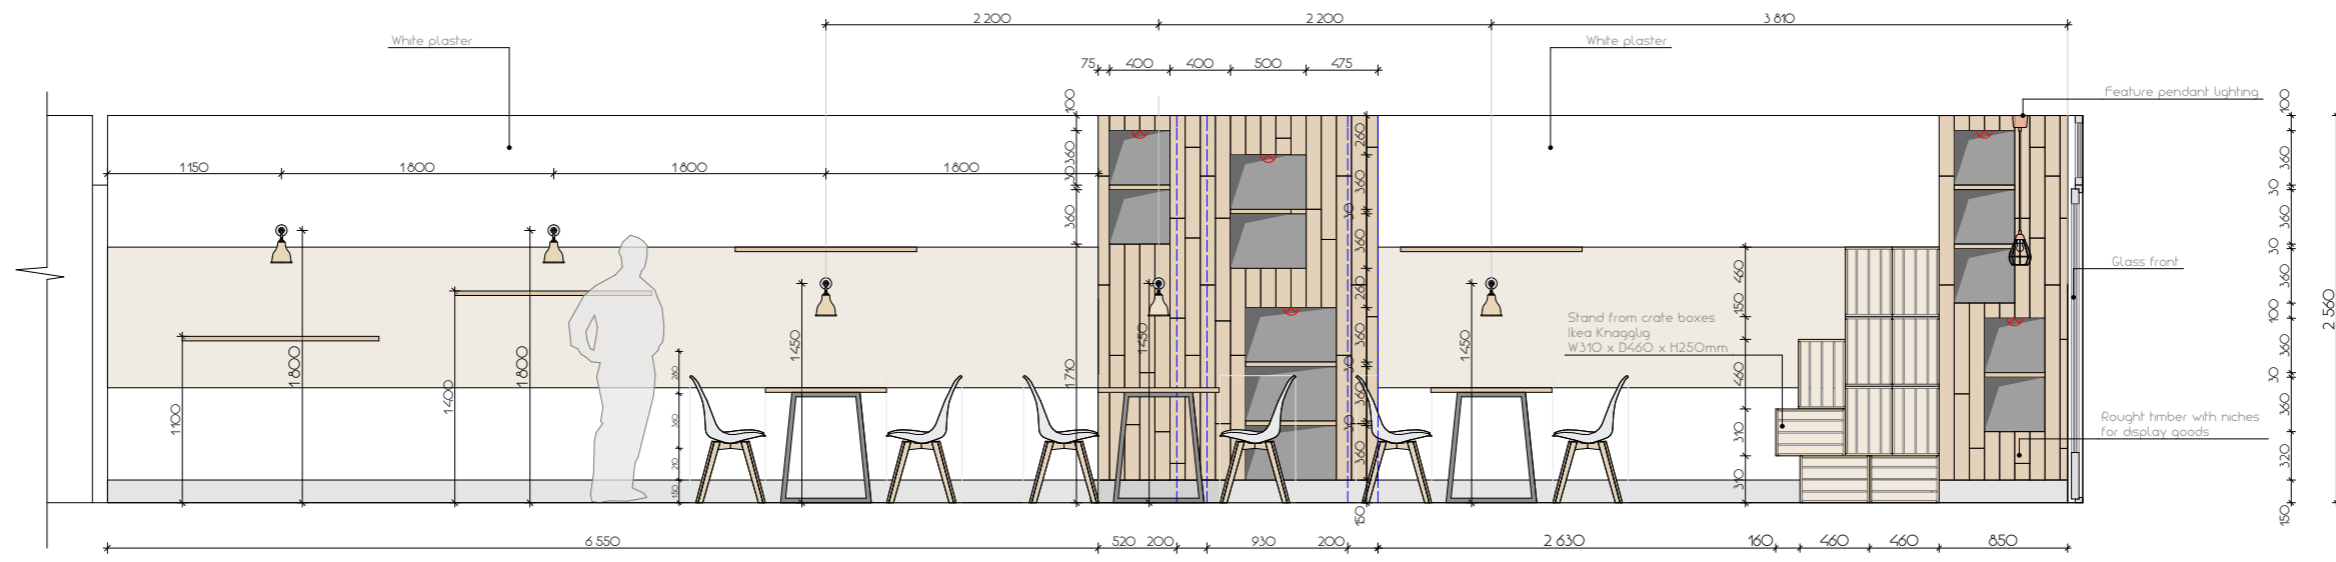

1 ELEVATION SEATING WALL
A-2 SCALE: 1:50


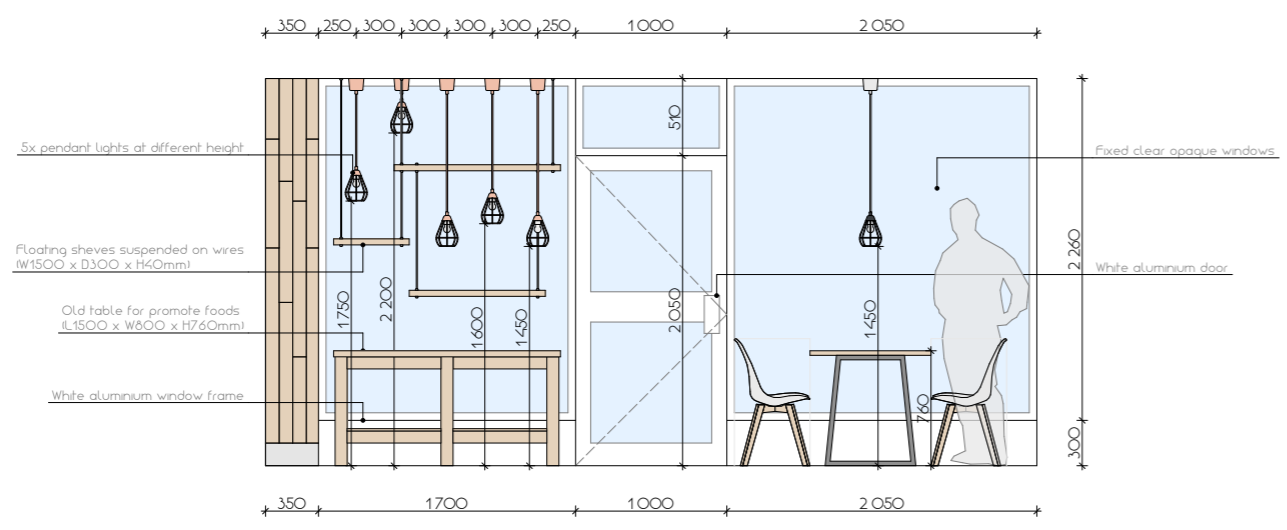


2 ELEVATION ENTRY WALL. OPTION 01
A-2 SCALE: 1:50

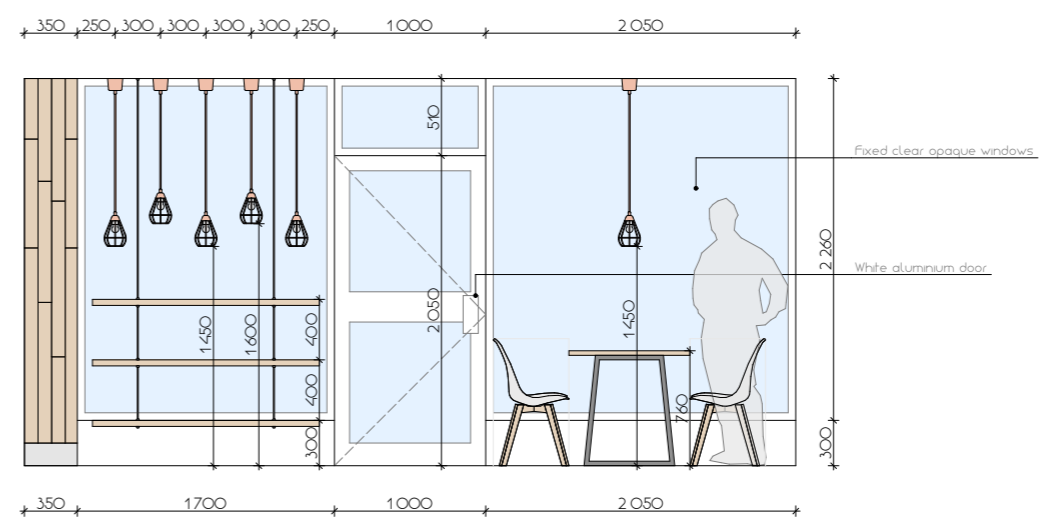


2 ELEVATION ENTRY WALL. OPTION 02
A-2 SCALE: 1:50


"Golden grain" coffee shop interior design, for unit Kingsway, BR49JF

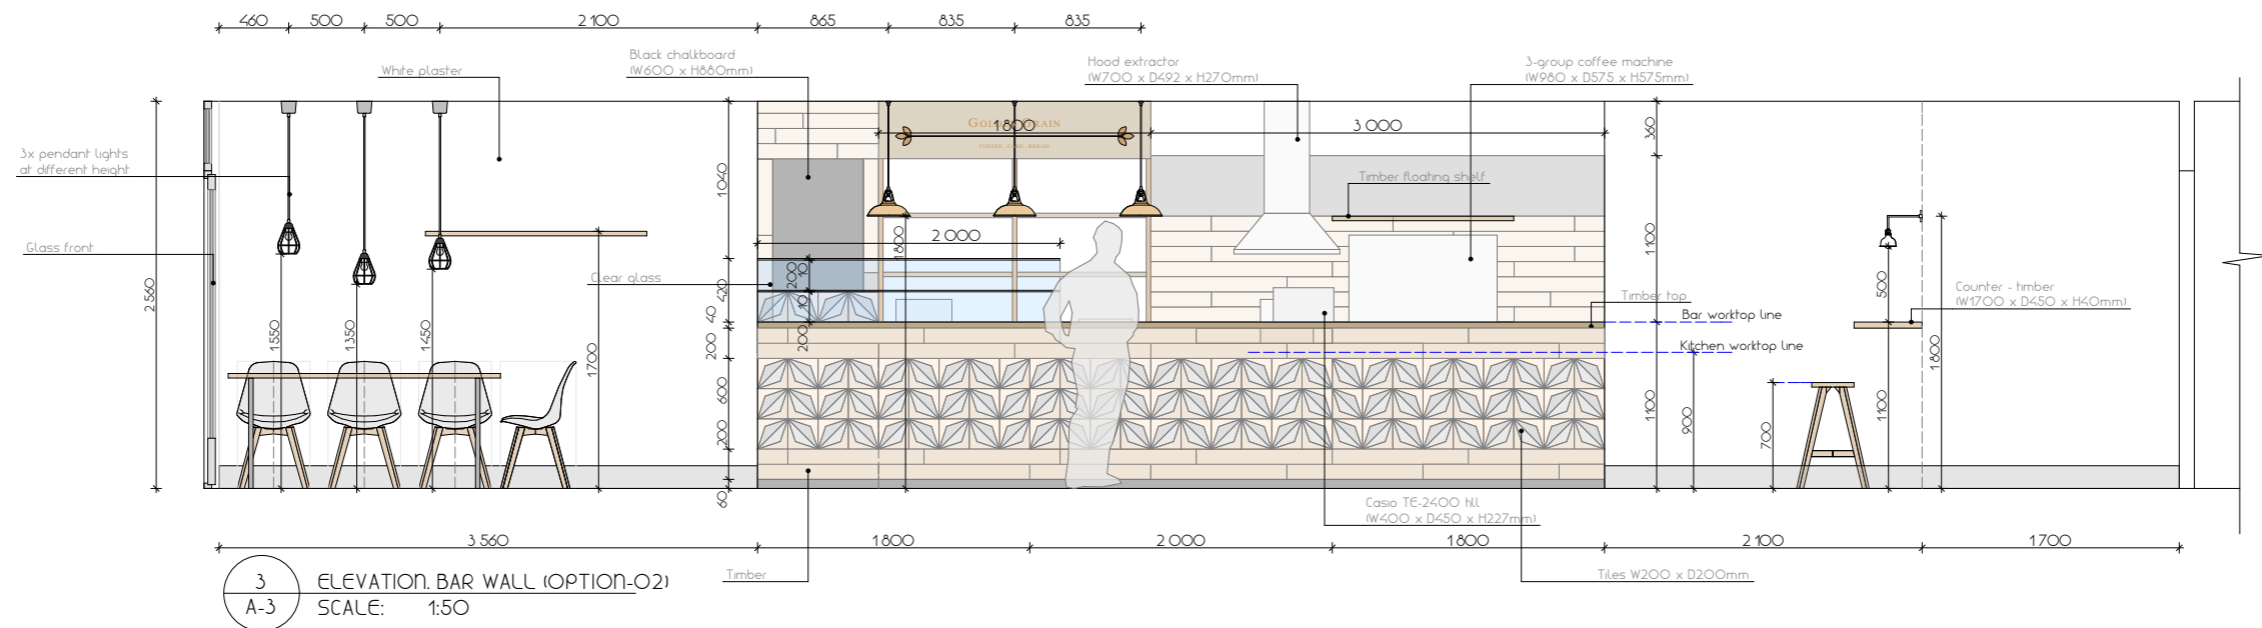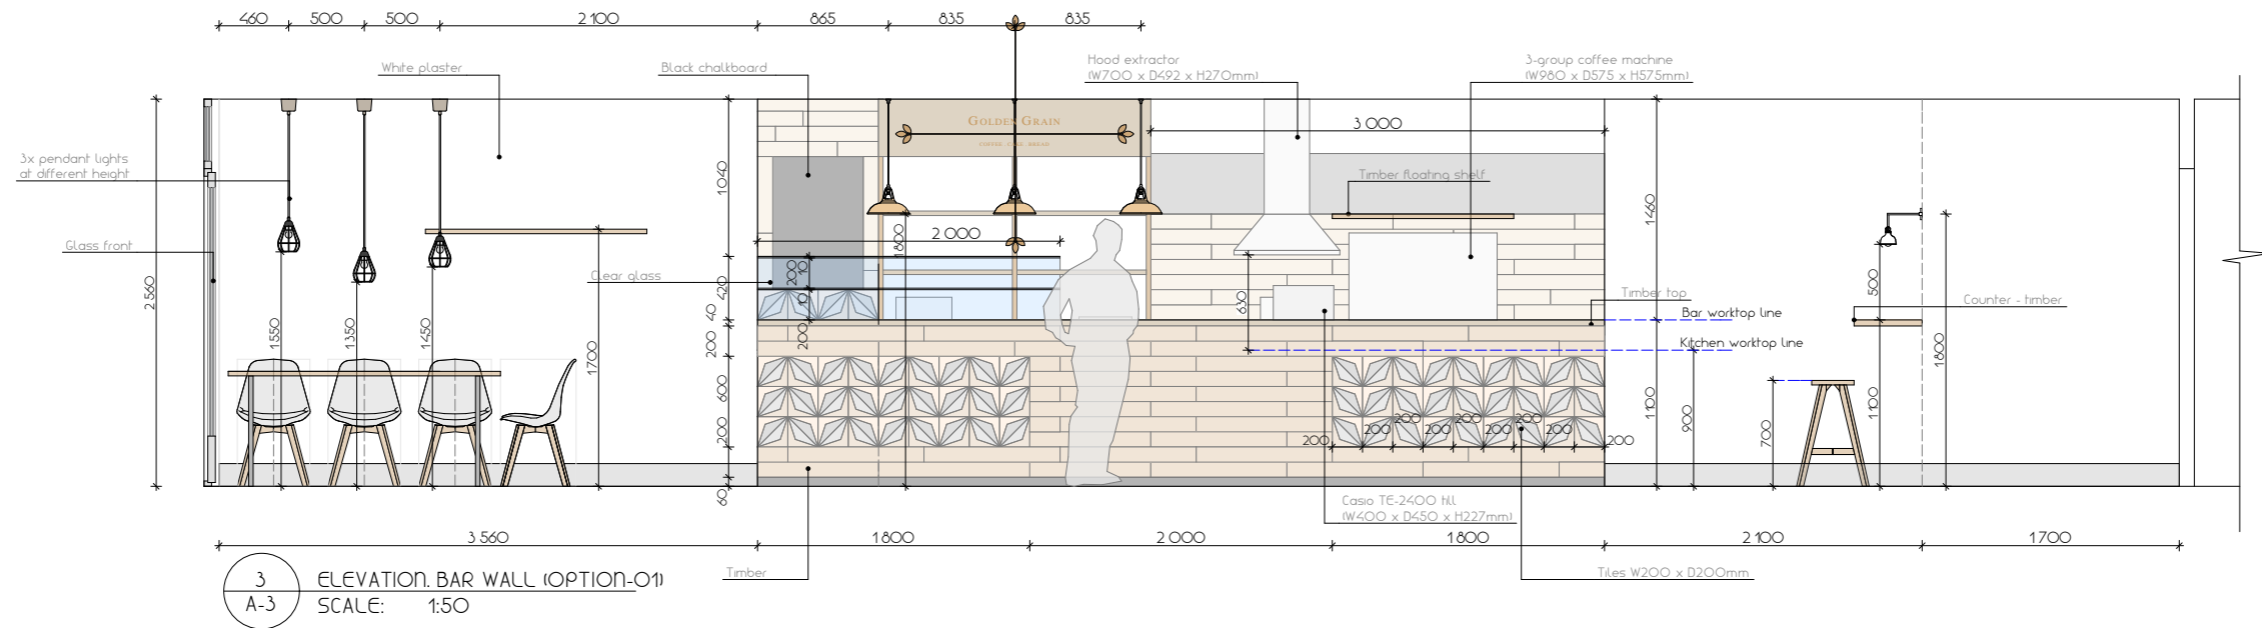

"Golden grain" coffee shop interior design, for unit Kingsway, BR49 JF

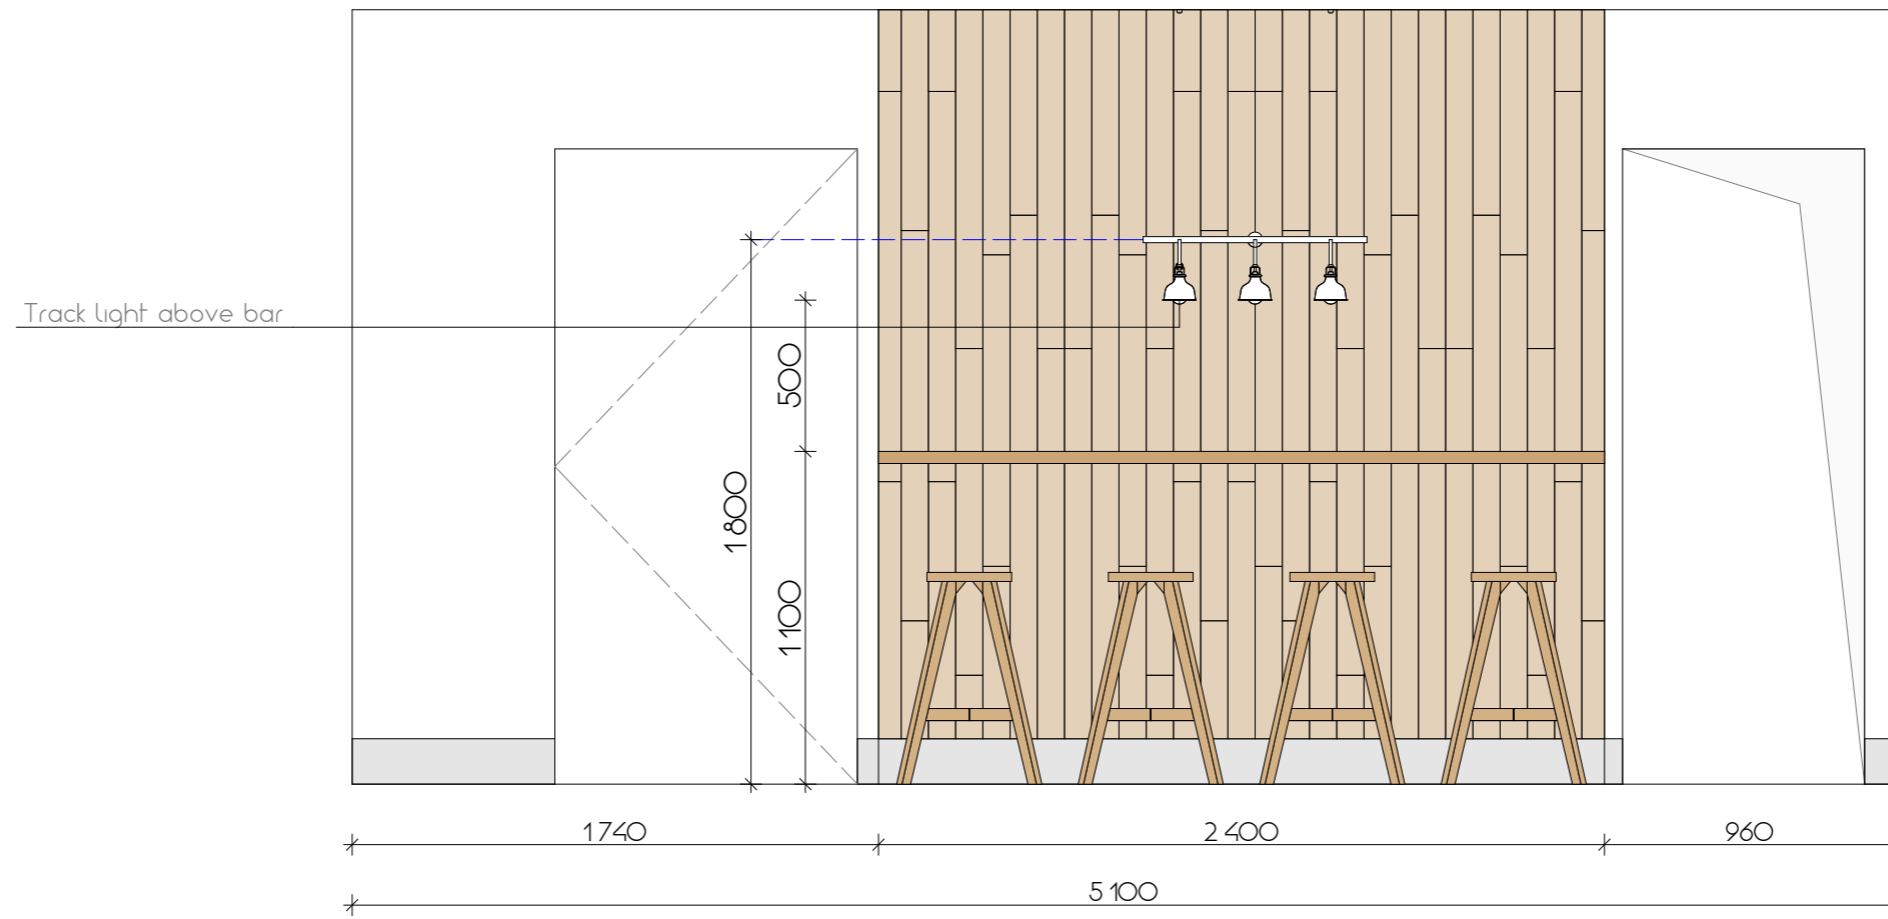

4
A-4 ELEVATION. OFFICE WALL
SCALE: 1:25

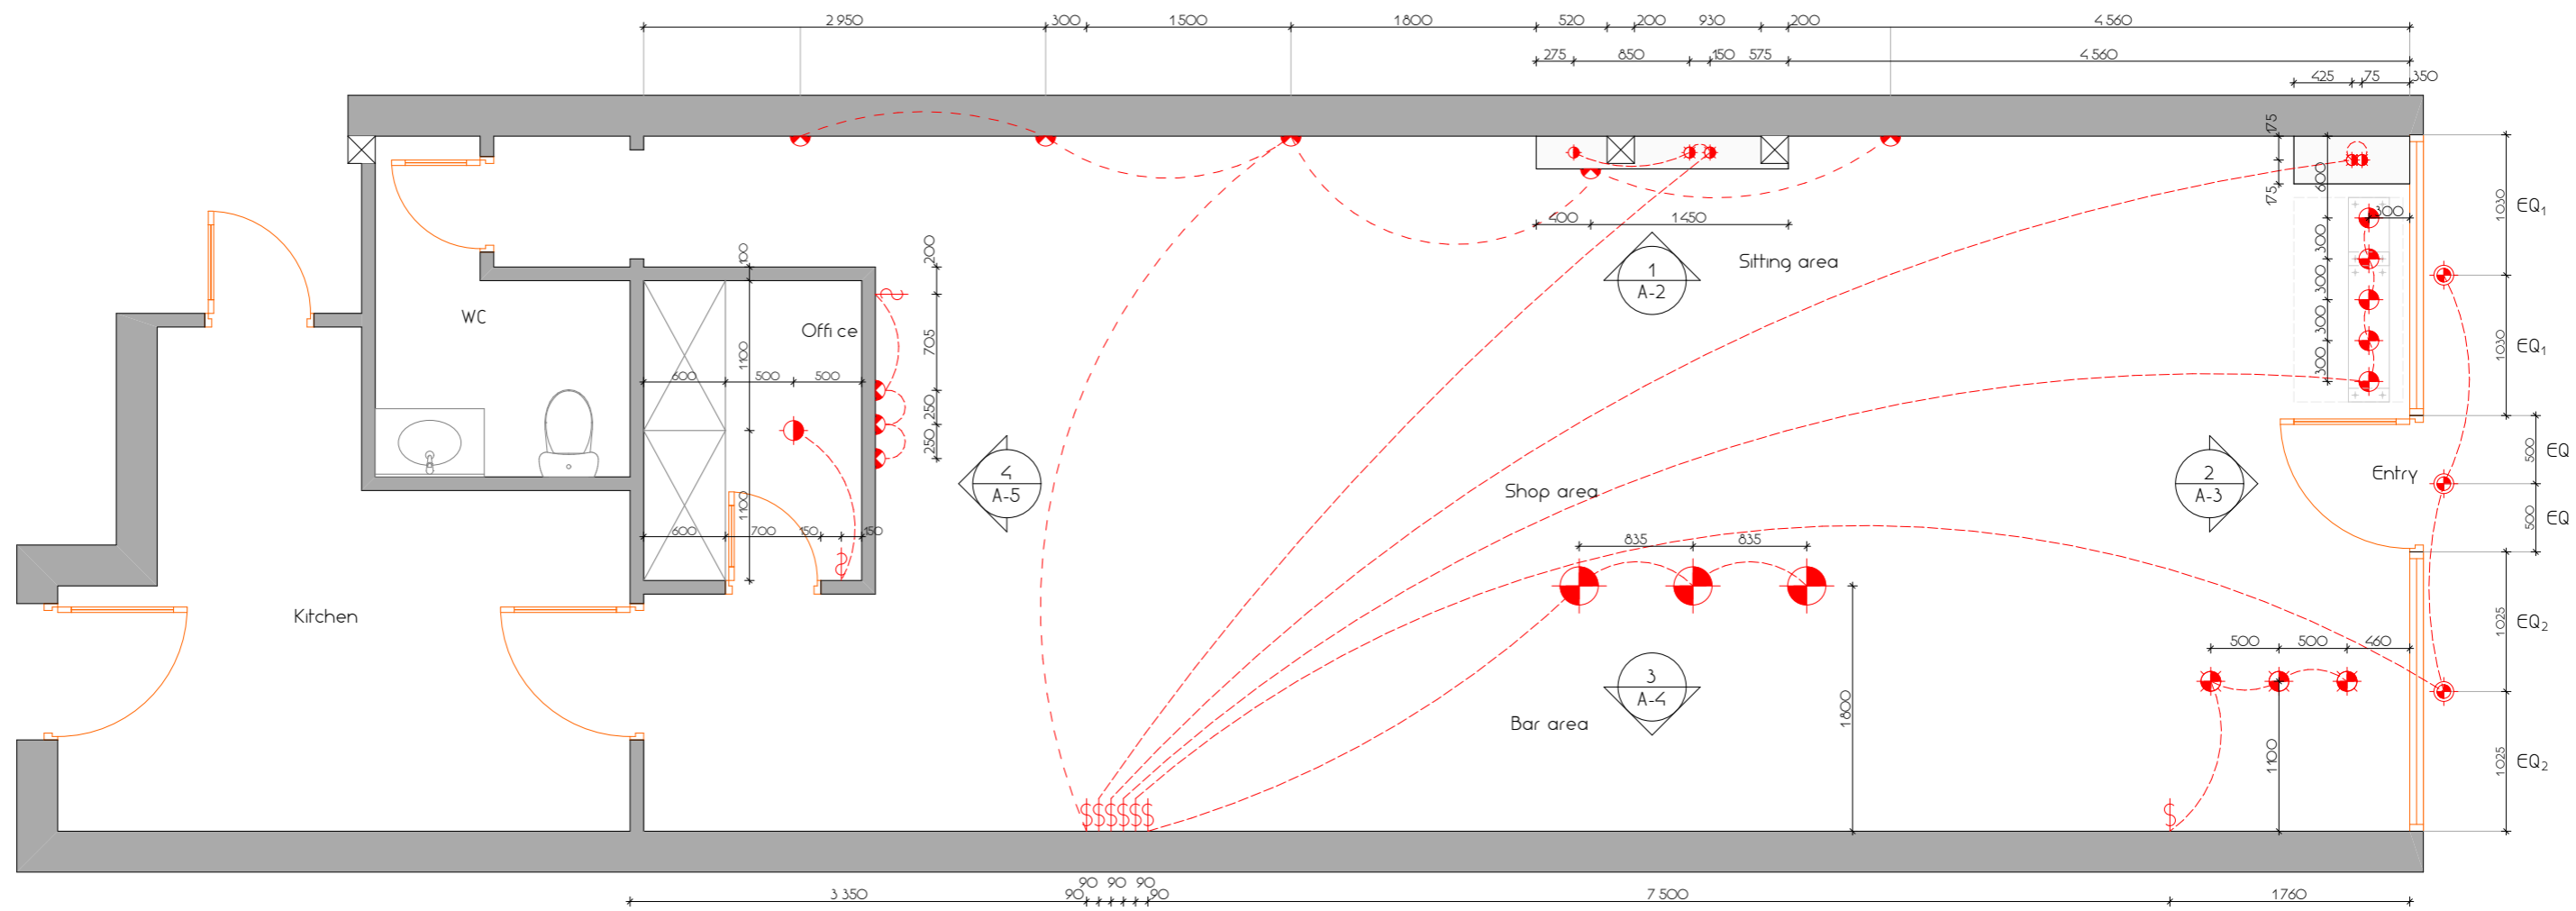


6 GOLDEN GRAIN CAFE. LIGHTING PLAN
A-6 SCALE: 1:75

ELECTRICAL LEGEND	
\$	LIGHT SWITCH
⊗	EXTERIOR LIGHT
⊙	CEILING MOUNTED LIGHT
⊕	CEILING PENDANT HANGING LIGHT
◩	INTERNAL WALL MOUNTED LIGHT
◪	LOW VOLTAGE LIGHT POINT

"Golden grain" coffee shop interior design, for unit Kingsway, BR49JF



5 ELEVATION, EXISTING SHOP FRONT
A-6 SCALE: 1:50

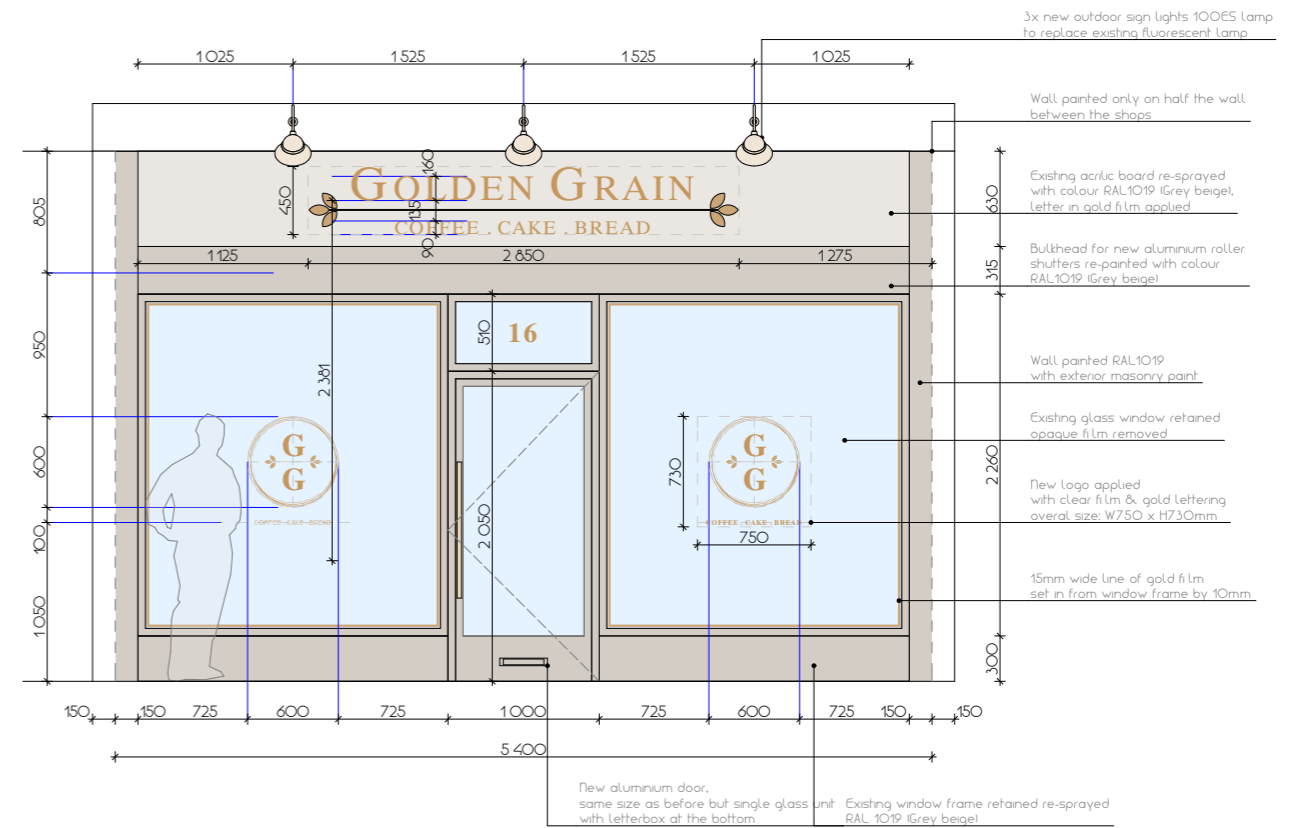

6 ELEVATION, PROPOSED SHOP FRONT
A-6 SCALE: 1:50

SCALE: 1:50 @ A3

SCALE: 1:50 @ A3

GOLDEN GRAIN
COFFEE . CAKE . BREAD

Proposed shop name



COFFEE . CAKE . BREAD

Proposed logo for windows

"Golden grain" coffee shop interior design, for unit Kingsway, BR49JF